


LEGEND

- N44,500 HANFORD PLANT COORDINATE
- E2,216,000 WASHINGTON STATE PLANE COORDINATE
- EXISTING FENCE
- △ SURVEY MONUMENT
- 693.2 • SPOT ELEVATION
- UTILITY POLE
- - - EXISTING OVERHEAD POWER LINES
- OH — OVERHEAD SERVICE
- LIGHT POLE & LUMINAIRE

POLE SCHEDULE				
POLE NO.	COORDINATES		LUMINAIRES	NOTES
	N	W		
P1	44,182	78,310	(2) 147 W	RSX2-LED-P3-40000-R4-MVOLT-MA-PER7-DBLXD
P2	44,070	78,330	(1) 147 W	RSX2-LED-P3-40000-R4-MVOLT-MA-PER7-DBLXD
P3	43,910	78,330	(1) 147 W	RSX2-LED-P3-40000-R4-MVOLT-MA-PER7-DBLXD
P4	44,260	78,330	(1) 147 W	RSX2-LED-P3-40000-R4-MVOLT-MA-PER7-DBLXD

LIGHTING MAY BE REPLACED WITH LIKE FOR LIKE, LIKE FOR KIND, RETROFIT KITS, AND LED UPGRADE PER DA DISCRETION.

DATE: Mar 06, 2024 HANFORD RELEASE

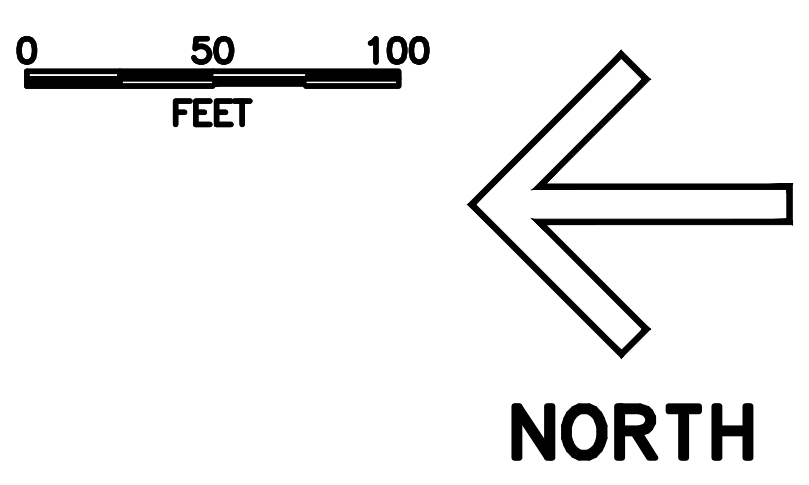

Approved for Public Release;
Further Dissemination Unlimited

BLDG. NO. 218W5	CAUTION NOT COMPLETE WITHOUT CURRENT CHANGE DOCUMENTS FROM DATABASE		ATTENTION DESTROY THIS DOCUMENT BY SHREDDING MAY CONTAIN SENSITIVE INFORMATION	
	DRAWN BY H0039958-RE MITCHELL	DATE 3/5/2024	U.S. DEPARTMENT OF ENERGY Richland Operations Office	
	DESIGNED BY H1773842-MM RICHARDS	DATE 3/5/2024	ELECTRICAL SITE PLAN RMW LAND DISPOSAL FACILITY NON-DRAG-OFF (TR-31)	
	ELECTRICAL ENGINEER H7665813-JT PEREZ	DATE 3/5/2024		
	DESIGN APPROVED BY H1773842-MM RICHARDS	DATE 3/5/2024		
	ENG. IN CHARGE H2031133-F AGUILAR	DATE 3/5/2024		
INDEX NO. 7401	REV. NO. 7	DESCRIPTION REVISED PER ECR-24-000191	SIZE F	DRAWING NUMBER H-2-131587
DRAWING TRACEABILITY LIST			SCALE AS SHOWN	SHEET 3
NEXT USED ON			REV 7	REV 7

REF NUMBER	TITLE	DESCRIPTION	REVISIONS
H-2-99275	TOPOGRAPHIC MAP LOW LEVEL BURIAL GROUND (SHEETS 2,3, AND 7)		