
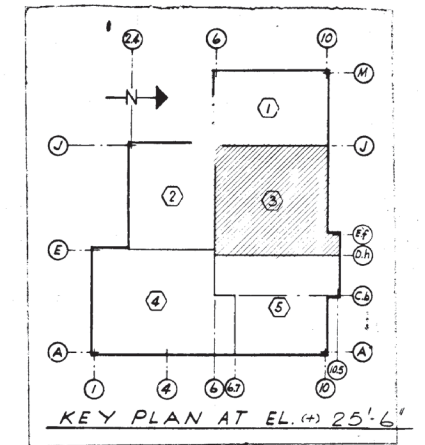


QTY.	PT. NO.	DESCRIPTION
------	---------	-------------

- NOTES:**
- FOR DETAILS OF STL STAIRS N° 6, 7 & 8 REF H-3-20184.
 - FOR DETAILS OF CONC STAIRS N° 12 REF H-3-20205.
 - INSTALL 1/4" BUTYL RUBBER FILLER OR APPROVED EQUAL AND CAULK THE VERTICAL CENTER GROOVES IN EACH METAL WALL PANEL, FLOOR TO CEILING.

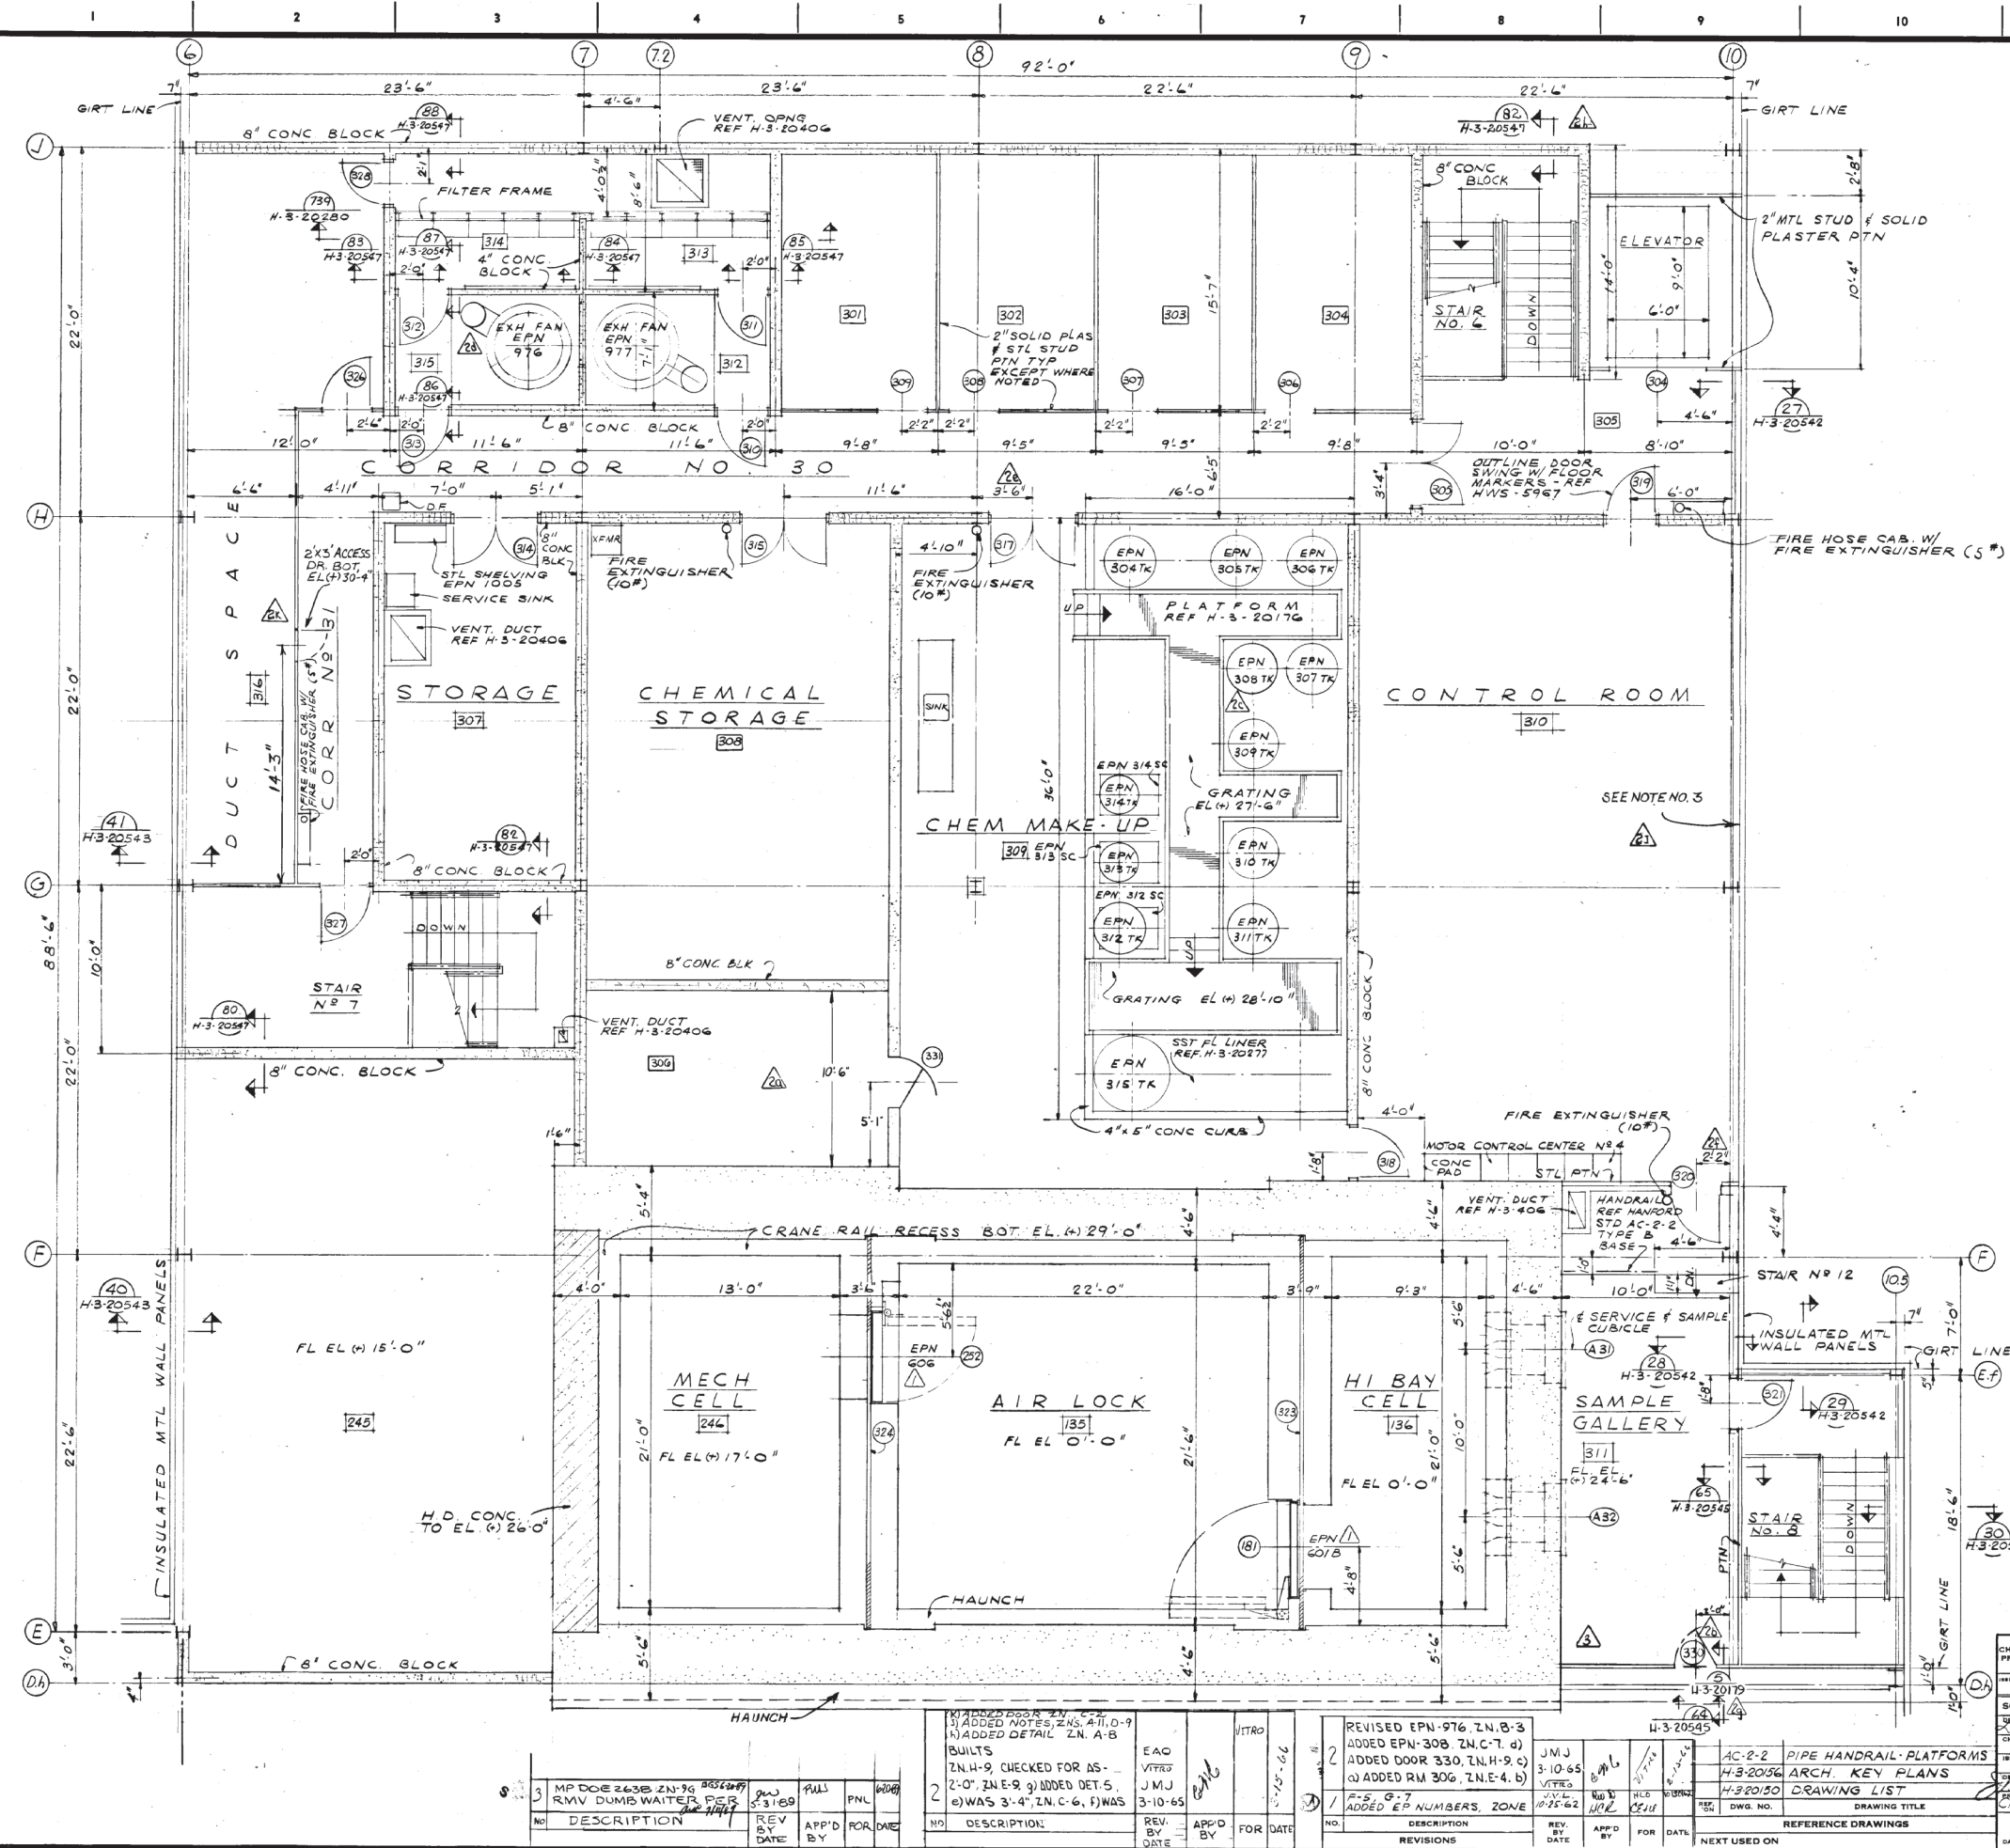

H-3-20167 SHEET 3

NO.	DESCRIPTION	REV. BY	DATE	APP'D BY	FOR DATE
1	ADDED DOOR IN CORRIDOR	JMJ	3-10-65		
2	ADDED NOTES Z.N. A-11, D-9	JMJ	3-10-65		
3	ADDED DETAIL Z.N. A-8	JMJ	3-10-65		
4	BUILTS	JMJ	3-10-65		
5	Z.N. H-9 CHECKED FOR AS-2-0"	JMJ	3-10-65		
6	Z.N. E-9, g) ADDED DET. 5	JMJ	3-10-65		
7	e) WAS 3'-4", Z.N. C-6, f) WAS	JMJ	3-10-65		

CHECK PRINT	APPROVED FOR CONST.	U. S. ATOMIC ENERGY COMMISSION
COMMENT PRINT	BY: [Signature]	HANFORD ATOMIC PRODUCTS OPERATION
DATE: 4-27-67	APPROVED FOR PURCHASE	GENERAL ELECTRIC
SCALE: 1/8" = 1'-0"	APPROVED FOR DESIGN	ARCHITECTURAL FLOOR PLAN EL. (+) 25'-6"
CHECKED BY: [Signature]	DATE: 4-27-67	AREA 3
DESIGNED BY: [Signature]	DATE: 4-27-67	FUELS RECYCLE PILOT PLANT
PROJECT: CAH 916	DATE: 4-27-67	NO. 324 INDEX 0890
CLASSIFIED BY: [Signature]	DATE: 4-27-67	OWN. NO. H-3-20167
DATE: 11/2/81	CLASSIFICATION: NONE	